


ELECTRICAL LEGEND	
	DBLE GPO @ 300 ABOVE F.L
	SGLE GPO FOR A/C
	CIRCUIT BOARD(POINT OF ENTRY)
	LIGHT SWITCH DOUBLE
	DBLE FLUORESCENT 2 x 36w
	EXTERNAL LIGHT

PANEL BUILDING SHORT SPECIFICATION :

- .. STEEL CHASSIS C/W GALV. JOISTS 75 x 40 x1.6mm @ MAX 400 CTRS
- .. 15mm PLYWOOD FLOORING
- .. 1.5mm VINYL FLOOR FINISH
- .. WALLS EXT 75mm PANEL c/w 0.4mm C/BOND FACINGS
- .. R1.8 POLYESTER INSULATION TO ROOF BETWEEN CEILING JOISTS
- .. GALV. STEEL CEILING / ROOF FRAME WITH SUPERDECK DECKING
- .. PRE-FINISHED PLYWOOD CEILINGS c/w ALUMIN. CORNICE
- .. COLORBOND ROOF FLASHINGS & CORNER TRIMS
- .. CEILING HEIGHT ..2400..

EQUIPMENT LIST:

- 1.. 2040 x 870 PLAIN METAL EXTERNAL DOOR
- 2.. 1050 x 1190 HORIZ. SLIDING WINDOW C/W FLYSCREEN
- 3.. LG REVERSE CYCLE AIR CONDITIONER

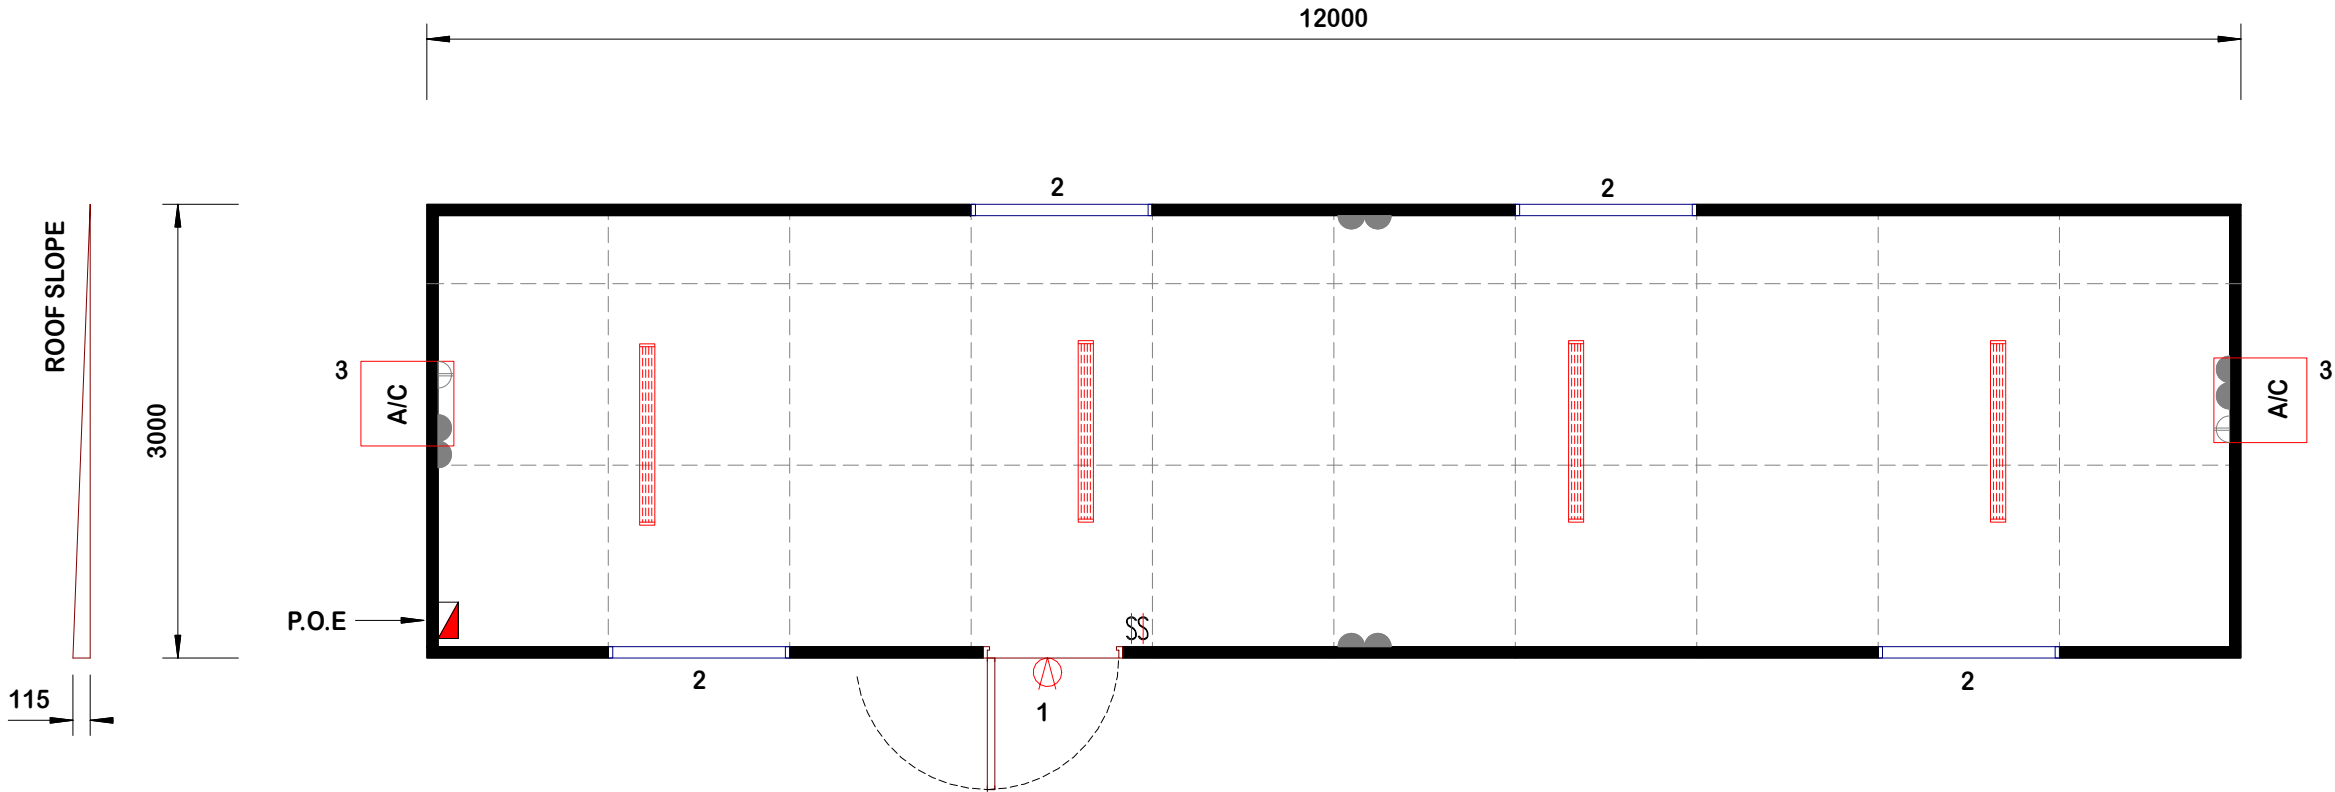

BUILDING DESIGN CRITERIA
 Wind Load - in Accordance with AS.1170.2:2002
 REGION A, TERRAIN CATEGORY 2
 Annual Probability of Exceedance 1:500
 REGIONAL WIND SPEED - V500 = 45 m/s

NOTE: THESE DRAWING ARE PROTECTED BY COPYRIGHT LAWS... DO NOT SCALE DRAWINGS..REF TO DIMENSIONS ONLY.	 555 WATERLOO CNR RD , BURTON S.A. 5110 PH: 8280 5500 FAX: 8280 5511 LOT 1101 - 1102 MOOLIGUNN RD , KARRATHA W.A. 6714 PH: 9144 4400 FAX: 9144 4430 HEAD OFFICE 21 CASINO ST WELSHPOOL W.A 6105 PH: 9353 2822 FAX: 9353 3866 DALGETY RD ALICE SPRINGS N.T. 0870 PH: 8952 1699 FAX: 8952 1177 LOT 1690 MCKINNON RD , BERRIMAH, DARWIN N.T. 0820 PH: 8932 4900 FAX: 8932 4888	CLIENT: FLEETWOOD PORTABLES		ORIGINAL SCALE: 1:50	
		TITLE: STANDARD 04-A		DWN BY: DCT	
		12 x 3m OFFICE		DATE: 25.05.05	
				DWG No 04-A	