
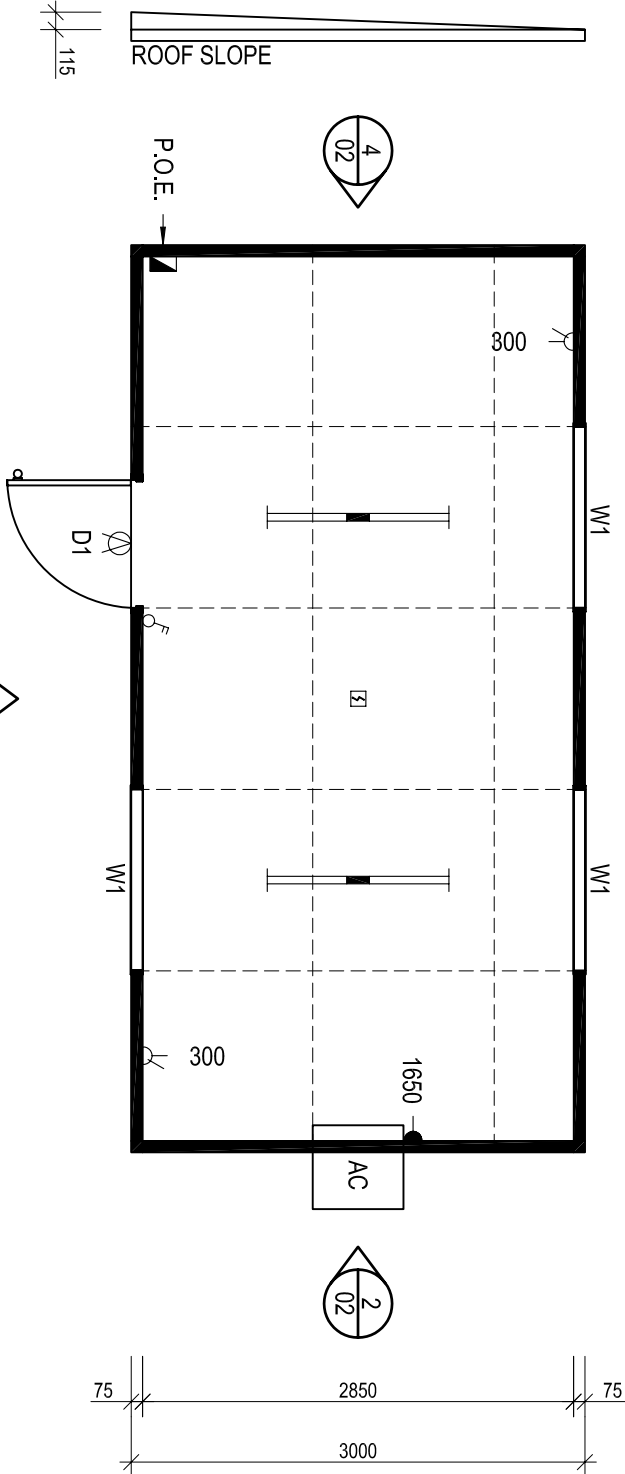


BUILDING DESIGN CRITERIA Wind Load - in Accordance with AS.1170.2.2002 REGION A, TERRAIN CATEGORY 2 Annual Probability of Exceedance 1:500 REGIONAL WIND SPEED - V500 = 45 m/s Built To: BUILDING CLASS 5	EXTERNAL DIMENSIONS -6.0m x 3.0m INTERNAL DIMENSIONS - 5.85m x 2.85m = 16.67m²
--	---

CEILING HEIGHT 2400

FIRE LEGEND		
DESCRIPTION	QTY	
☒ SMOKE DETECTOR : HARD WIRED	1	
MISCELLANEOUS	0	

ELECTRICAL LEGEND		
DESCRIPTION	QTY	
⚡ → CIRCUIT BREAKER BOARD : (POINT of ENTRY)	1	
⚡ SWITCH : LIGHT : DOUBLE	1	
⚡ LIGHT : 2x36w FLUORESCENT : DIFFUSED	2	
⚡ LIGHT : EXTERNAL BULKHEAD : W/PROOF	1	
⚡ GPO : 10 AMP DOUBLE : HEIGHT SHOWN	2	
⚡ GPO : 15 AMP SINGLE : HEIGHT SHOWN	1	
0amps TOTAL BUILDING AMPAGE - SINGLE PHASE		

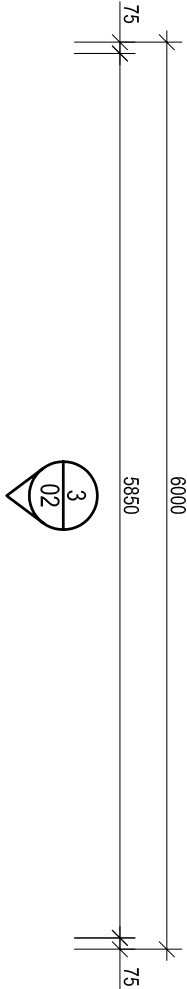

PLAN VIEW

scale 1:50

EQUIPMENT LIST	
No.	DESCRIPTION
D1	2040h x 820w PLAIN METAL EXTERNAL DOOR
W1	1050h x 1190w HORIZ. SLIDING WINDOW c/w FLYSCREEN
AC	WALL MOUNTED REVERSE CYCLE AIR CONDITIONER (1HP)
QTY	
1	
3	
1	

PANEL BUILDING SHORT SPECIFICATION REG A	
- CHASSIS - STEEL BEAMS c/w GALV. JOISTS 75 x 40 CEE SECTIONS @ MAX 400 CTRS - FLOORING - 22mm T&G AQUATITE TERMITTE TREATED PARTICLE BOARD - FLOOR COVERING - 1.5mm VINYL FLOOR FINISH - EXTERNAL WALLS - 75mm PANEL c/w 0.4mm COLORBOND facings - refer colour schedule - ROOF INSULATION - R1.8 POL YESTER INSULATION between ceiling joists with - THERMALBREAK under roof sheets - TOTAL ROOF RATING R3.6 - ROOF & CEILING FRAME - GALV. STEEL FRAMEWORK - ROOF CLADDING - SUPERDEK SHEETING - refer colour schedule - CEILING - PRE-FINISHED PL VWOOD c/w ALUMINIUM CORNICE - ROOF FLASHINGS & CORNER TRIMS - COLORBOND - refer colour schedule - DOOR FRAMES - METAL POWDERCOATED FINISH - refer colour schedule	

COLOUR SCHEDULE	
ROOF DECKING	- COLORBOND
ROOF FLASHING	- DEEP OCEAN
EXT WALLS	- PAPER BARK
INT WALLS	- SURFMIST
CEILING	- MIRAGE PEARL
WINDOWS	- DEEP OCEAN
EXT DOOR FRAME	- DEEP OCEAN
VINYL	- SLATE GREY
LOGOS	- YES
PERIMETER / BASE CHANNEL	- BLACK OXIDE

A		ISSUED FOR CONSTRUCTION			
REV		DESCRIPTION		DD	28-01-10
DRAWN BY:		DATE:	CHECKED BY:	DATE:	SCALE:
DD		28-01-10			1:50
THIS DRAWING IS PROTECTED BY COPYRIGHT LAWS © 2009			DO NOT SCALE: REFER TO DIMENSIONS ONLY		

	
Fleetwood	

HEAD OFFICE	
1240 ABERNETHY RD HIGH WYCOMBE W.A. 6057	
PH: (08) 9281 7500 FAX: (08) 9281 7580	
EMAIL: info@fleetwood.com.au INTERNET: www.fleetwood.com.au	
INTERSTATE BRANCHES:	
DAILEY RD ALICE SPRINGS N.T. 0870	553 WATERLOO CNR RD. BURTON S.A. 5110
PH: 8962 1699 FAX: 8952 1177	PH: 8280 5500 FAX: 8280 5511
58 MCKINNON RD. BERRIMAH DARWIN	
N.T. 0820 PH: 8932 4900 FAX: 8932 4888	
CLIENT:	
Adelaide Fleetwood	
LOCATION:	
Adelaide Rental Stock	

TITLE:			
OFFICE 6.0m x 3.0m - PLAN VIEW			
DWG NO:	JOB NO:	REV:	SHEET:
02-A-WM	S9086	A	A3