


BUILDING DESIGN CRITERIA Wind Load - in Accordance with AS.1170.2.2002 REGION A, TERRAIN CATEGORY 2 Annual Probability of Exceedance 1:500 REGIONAL WIND SPEED - V500 = 45 m/s Built To: BUILDING CLASS 10a	EXTERNAL DIMENSIONS - 4.8m x 3.0m INTERNAL DIMENSIONS - 4.65m x 2.85m = 13.25m² EXTERNAL AREA - 14.46m² PERIMETER - 15.6m² CEILING HEIGHT - 2.4m
---	---

ELECTRICAL LEGEND		
DESCRIPTION		QTY
CIRCUIT BREAKER BOARD : (POINT of ENTRY)		1
SWITCH : LIGHT : DOUBLE		1
LIGHT : OYSTER FITTING		2
LIGHT : EXTERNAL BULKHEAD : W/PROOF		1
FAN : 10 AMP SINGLE : HEIGHT SHOWN		1
FAN : EXHAUST : WALL MOUNTED		1
0amps TOTAL BUILDING AMPAGE - SINGLE PHASE		

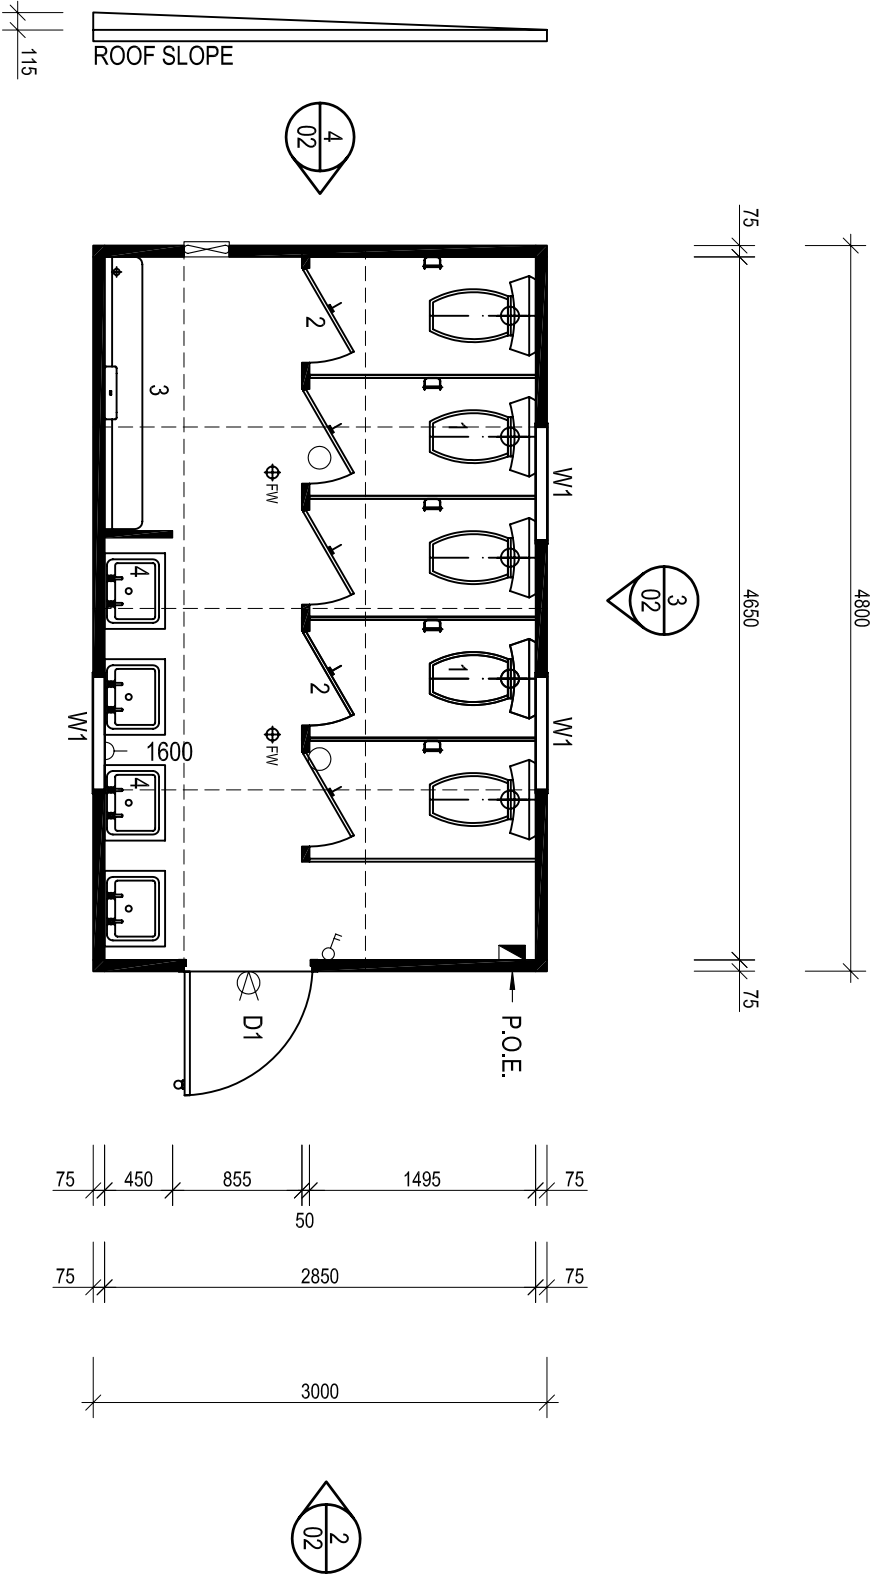

EQUIPMENT LIST		
No.	DESCRIPTION	QTY
D1	2040h x 820w PLAIN METAL EXTERNAL DOOR	1
W1	350h x 750w mm ALUMINIUM SLIDING WINDOW (OBSURED GLASS)	3
1	TOILET PAN c/w DUAL FLUSH CISTERN & PAPER HOLDER	5
2	TOILET CUBICLE c/w 600 DOOR & INDICATOR BOLT	5
3	1800 LONG S.S. WALL MOUNTED URINAL c/w CISTERN	1
4	S.S. HAND BASIN c/w MIRROR & SHELF OVER	4

PANEL BUILDING SHORT SPECIFICATION REG A	
- CHASSIS- STEEL BEAMS c/w GALV. JOISTS 75 x 40 CEE SECTIONS @ MAX 400 CTRS - FLOORING - 22mm T&G AQUATITE TERMITTE TREATED PARTICLE BOARD 2.0mm SLIP RESISTANT VINYL FLOOR FINISH c/w 100mm HIGH COVING TO WET AREAS - EXTERNAL WALLS - 75mm PANEL c/w 0.4mm COLORBOND facings - refer colour schedule - INTERNAL WALLS - 50mm PANEL c/w 0.4mm COLORBOND facings - refer colour schedule - ROOF INSULATION - R1.8 POL YESTER INSULATION between ceiling joists with THERMALBREAK under roof sheets - TOTAL ROOF RATING R3.6 - ROOF & CEILING FRAME - GALV. STEEL FRAMEWORK - ROOF CLADDING - SUPERDEK SHEETING - refer colour schedule - CEILING - PRE-FINISHED PL WOOD c/w ALUMINIUM CORNICE - ROOF FLASHINGS & CORNER TRIMS - COLORBOND - refer colour schedule - DOOR FRAMES - METAL POWDERCOATED FINISH - refer colour schedule	

COLOUR SCHEDULE	
ROOF DECKING	- COLORBOND
ROOF FLASHING	- DEEP OCEAN
EXT WALLS	- PAPER BARK
INT WALLS	- SURFMIST
CEILING	- MIRAGE PEARL
WINDOWS	- DEEP OCEAN
EXT DOOR FRAME	- DEEP OCEAN
VINYL TO WET AREAS	- WOODLAND GREY
LOGOS	- YES
PERIMETER / BASE CHANNEL	- BLACK OXIDE

1240 ABERNETHY RD HIGH WYCOMBE W.A. 6057

PH: (08) 9281 7500 FAX: (08) 9281 7580

EMAIL: info@fleetwood.com.au

INTERSTATE BRANCHES:

DALGETY RD ALICE SPRINGS N.T. 0870 PH: 8952 1699 FAX: 8952 1177

555 WATERLOO CNR RD. BURTON S.A. 5110 PH: 8280 5500 FAX: 8280 5511

58 MCKINNON RD. BERRIMAH, DARWIN N.T. 0820 PH: 8932 4900 FAX: 8932 4888

CLIENT:

BADGE CONSTRUCTION

LOCATION:

TBA

TITLE:

TOILET 4.8m x 3.0m - PLAN VIEW

DWG No:

T4-A

JOB No:

REV:

A

SHEET:

A3

THIS DRAWING IS PROTECTED BY COPYRIGHT LAWS © 2009

DO NOT SCALE. REFER TO DIMENSIONS ONLY

A	QUOTATION		DD	05-02-10
REV	DESCRIPTION		INT	DATE
DRAWN BY:	DATE:	CHECKED BY:	DATE:	SCALE:
DD	05-02-10			1:50

