


BUILDING DESIGN CRITERIA Wind Load - in Accordance with AS:1170:22002 REGION A & B, TERRAIN CATEGORY 2 Annual Probability of Exceedance 1:500 MAX REGIONAL WIND SPEED - V500 = 57 m/s Built To: BUILDING CLASS 10A	EXTERNAL DIMENSIONS - 3.0m x 3.0m INTERNAL DIMENSIONS -2.85m x 2.85m = 8.12m²
--	--

CEILING HEIGHT 2400

ELECTRICAL LEGEND		
DESCRIPTION	QTY	
 CIRCUIT BREAKER BOARD : (POINT of ENTRY)	1	
 SWITCH : LIGHT : DOUBLE : W/PROOF	1	
 LIGHT : OYSTER FITTING	1	
 LIGHT : EXTERNAL BULKHEAD : W/PROOF	1	
 GPO : 10 AMP SINGLE : HEIGHT SHOWN	1	
 FAN : EXHAUST : WALL MOUNTED	1	
0amps TOTAL BUILDING AMPPAGE - SINGLE PHASE		

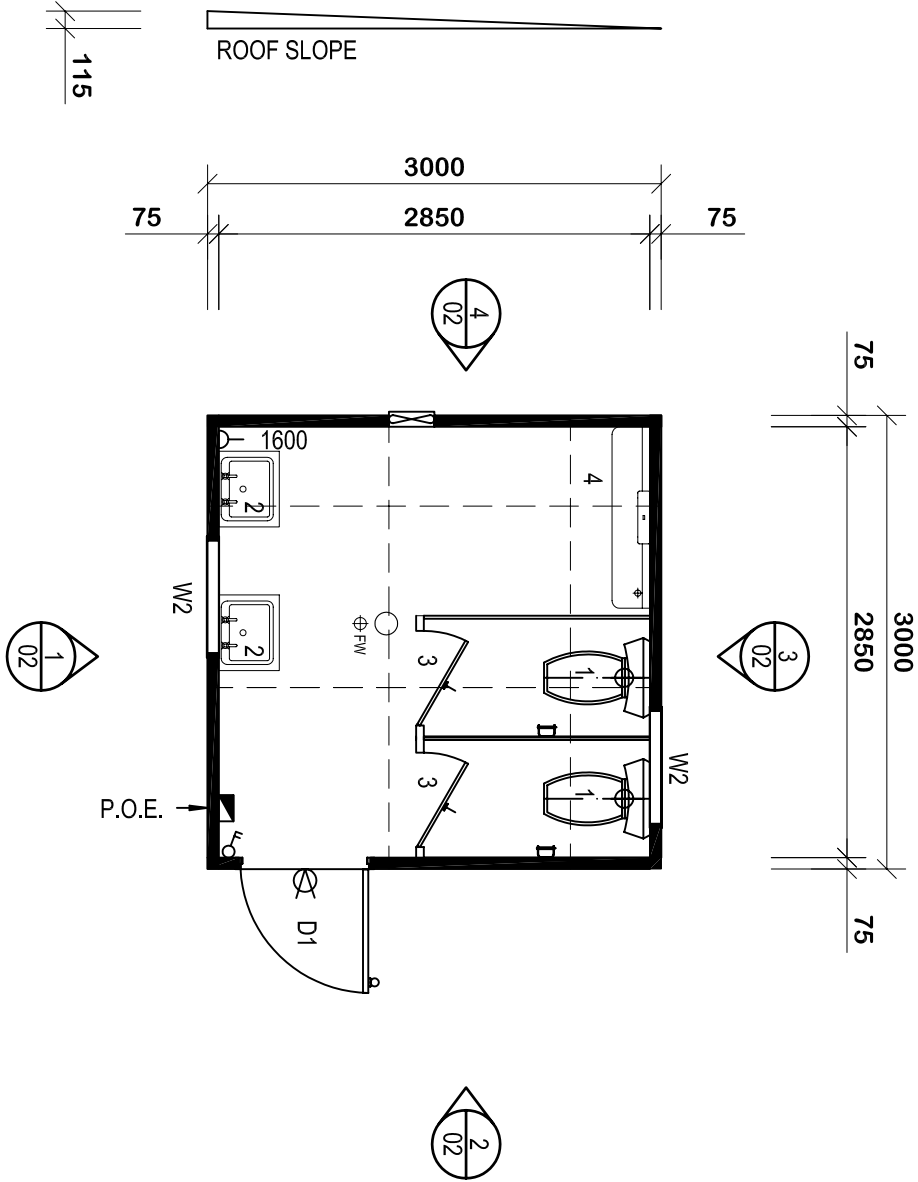

PLAN VIEW
scale 1:50

EQUIPMENT LIST	
No.	DESCRIPTION
D1	2040 x 820 PLAIN METAL EXTERNAL DOOR
W2	350 x 750 FIXED VENTED WINDOWS C/W FLYSCREEN
1	TOILET PAN C/W DUAL FLUSH CISTERN & PAPER HOLDER
2	S.S. HANDBASIN C/W MIRROR & SHELF OVER
3	800 WIDE TOILET CUBICLE C/W 600 WIDE DOOR & INDICATOR BOLT
4	1200 LONG WALL HUNG S.S. URINAL C/W CISTERN

A		ISSUED FOR CONSTRUCTION			
REV		DESCRIPTION		DD	
DRAWN BY:		DATE:		SCALE:	
DD		20-10-09		1:50	
THIS DRAWING IS PROTECTED BY COPYRIGHT LAWS © 2007				DO NOT SCALE. REFER TO DIMENSIONS ONLY	

 Fleetwood			
HEAD OFFICE			
1240 ABERNETHY RD HIGH WYCOMBE W.A. 6057			
PH: (08) 9281 7500 FAX: (08) 9281 7580			
EMAIL: info@fleetwood.com.au INTERNET: www.fleetwood.com.au			
INTERSTATE BRANCHES:			
DALGETY RD ALICE SPRINGS N.T. 0870			
PH: 8852 1699 FAX: 8852 1177			
555 WATERLOO CNR RD. BURTON S.A. 5110			
PH: 8280 5500 FAX: 8280 5511			
58 MCKINNON RD. BERRIMAH DARWIN			
N.T. 0820 PH: 8932 4900 FAX: 8932 4888			
CLIENT:			
FLEETWOOD STOCK			
LOCATION:			
FLEETWOOD STANDARD			
TITLE:			
TOILET 3.0 x 3.0m - FLOOR PLAN			
DWG No:	JOB No:	REV:	SHEET:
T2-A		A	A3