


BUILDING DESIGN CRITERIA Wind Load - in Accordance with AS1170.2:2002 REGION A & B, TERRAIN CATEGORY 2 Annual Probability of Exceedance 1:500 MAX REGIONAL WIND SPEED - V500 = 57 m/s Built To: BUILDING CLASS 6	EXTERNAL DIMENSIONS - 6.0m x 3.0m INTERNAL DIMENSIONS - 5.85m x 2.85m INTERNAL AREA - 16.7m²
--	---

CEILING HEIGHT 2400

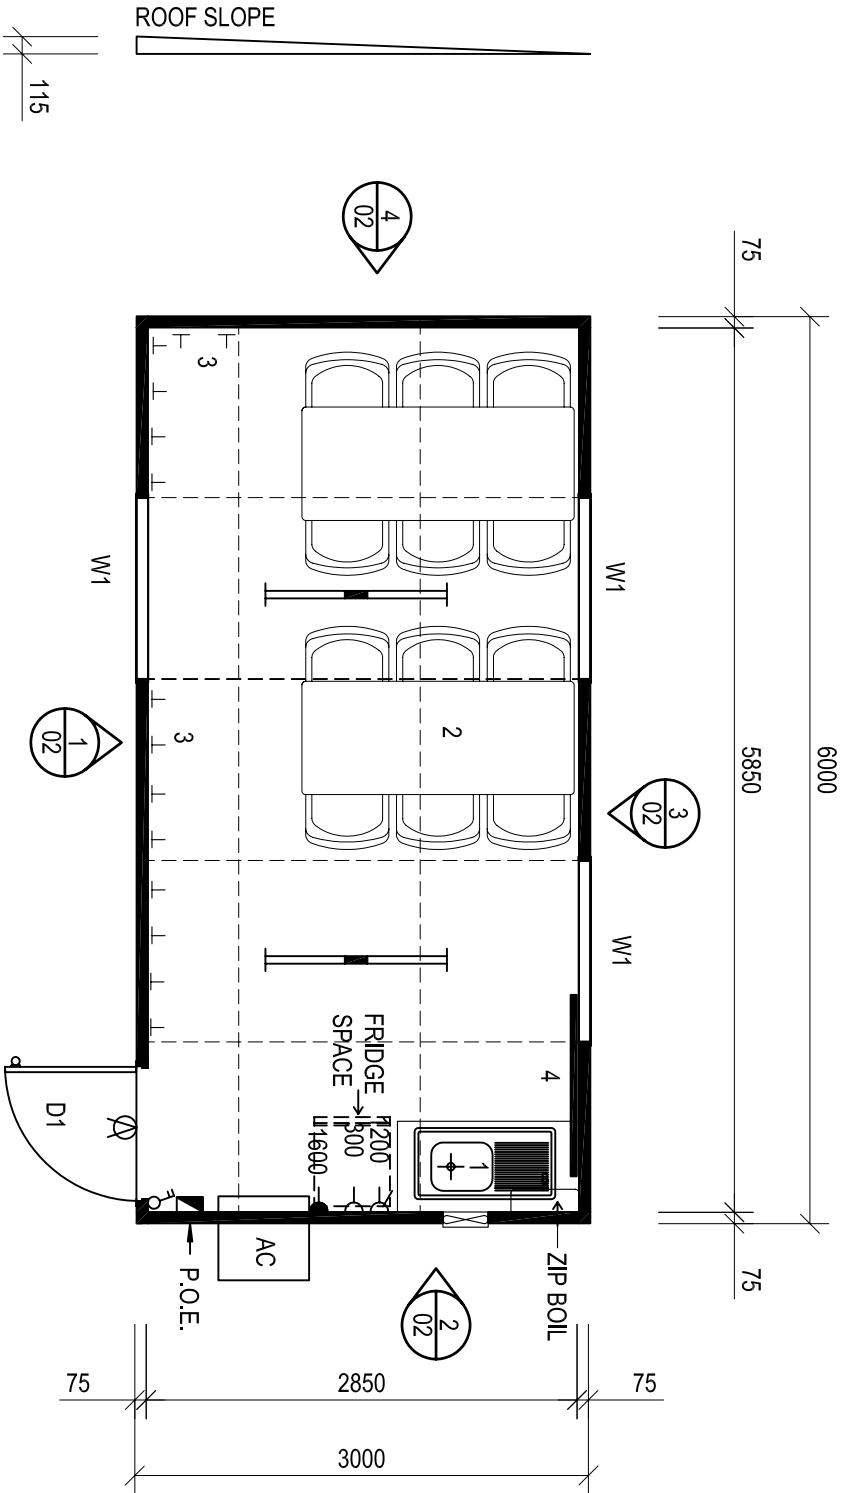

EQUIPMENT LIST	
No.	DESCRIPTION
AC	WALL MOUNTED AIR CONDITIONER (HP1)
D1	2040h x 870w EXTERNAL DOOR
W1	1050h x 1190w HORIZ. SLIDING WINDOW c/w FLYSCREEN
1	600 DEEP CRIB CUP/D C/W LAM. TOP & 930 LONG S.S.SINK
2	750 x 1800 DINING TABLE C/W PVC 6 STACK CHAIRS
3	COAT HOOKS @ 300 CTRS
4	PIN UP NOTICE BOARD

ELECTRICAL LEGEND	
DESCRIPTION	QTY
CIRCUIT BREAKER BOARD : (POINT of ENTRY)	1
SWITCH : LIGHT : DOUBLE	1
LIGHT : 2x36w FLUORESCENT : DIFFUSED	2
LIGHT : EXTERNAL BULKHEAD : W/PROOF	1
GPO : 10 AMP DOUBLE : HEIGHT SHOWN	1
GPO : 10 AMP SINGLE : HEIGHT SHOWN	1
FAN : EXHAUST : WALL MOUNTED	1
GPO : 15 AMP SINGLE : HEIGHT SHOWN	1
0amps TOTAL BUILDING AMPAGE - SINGLE PHASE	

THIS DRAWING IS PROTECTED BY COPYRIGHT LAWS © 2007		DO NOT SCALE. REFER TO DIMENSIONS ONLY	
HEAD OFFICE 1240 ABERNETHY RD HIGH WYCOMBE W.A. 6057 PH: (08) 9281 7500 FAX: (08) 9281 7580 EMAIL: info@fleetwood.com.au INTERSTATE BRANCHES: DALGETY RD ALICE SPRINGS N.T. 0870 PH: 8952 1699 FAX: 8952 1177 555 WATERLOO CNR RD. BURTON S.A. 5110 PH: 8280 5500 FAX: 8280 5511 58 MCKINNON RD. BERRIMAH, DARWIN N.T. 0820 PH: 8932 4900 FAX: 8932 4888			
CLIENT: FLEETWOOD			
LOCATION: FLEETWOOD STANDARD			
TITLE: LUNCH ROOM 6.0m x 3.0m - FLOOR PLAN			
DWG No: LR3-A-WM	JOB No:	REV: A	SHEET: A3