


EXTERNAL DIMENSIONS - 14.4m x 3.0m  
EXTERNAL AREA - 43.2m<sup>2</sup>  
EXTERNAL PERIMETER - 34.8m  
CEILING HEIGHT - 2.4m

| ELECTRICAL LEGEND                                                                   |                                    |     | ELECTRICAL LEGEND                                                                   |                                          |     |
|-------------------------------------------------------------------------------------|------------------------------------|-----|-------------------------------------------------------------------------------------|------------------------------------------|-----|
|                                                                                     | DESCRIPTION                        | QTY |                                                                                     | DESCRIPTION                              | QTY |
|  | SMOKE DETECTOR : HARD WIRED        | 2   |  | CIRCUIT BREAKER BOARD : (POINT of ENTRY) | 1   |
|  | GPO : 10 AMP SINGLE : HEIGHT SHOWN | 2   |  | SWITCH : LIGHT : DOUBLE                  | 2   |
|  | GPO : 15 AMP SINGLE : HEIGHT SHOWN | 2   |  | LIGHT : 2x36W FLUORESCENT : DIFFUSED     | 4   |
|  | FAN : EXHAUST : WALL MOUNTED       | 2   |  | LIGHT : OYSTER FITTING                   | 3   |
|  | GPO : 10 AMP DOUBLE : HEIGHT SHOWN | 10  |  | LIGHT : EXTERNAL BULKHEAD : W/PROOF      | 2   |

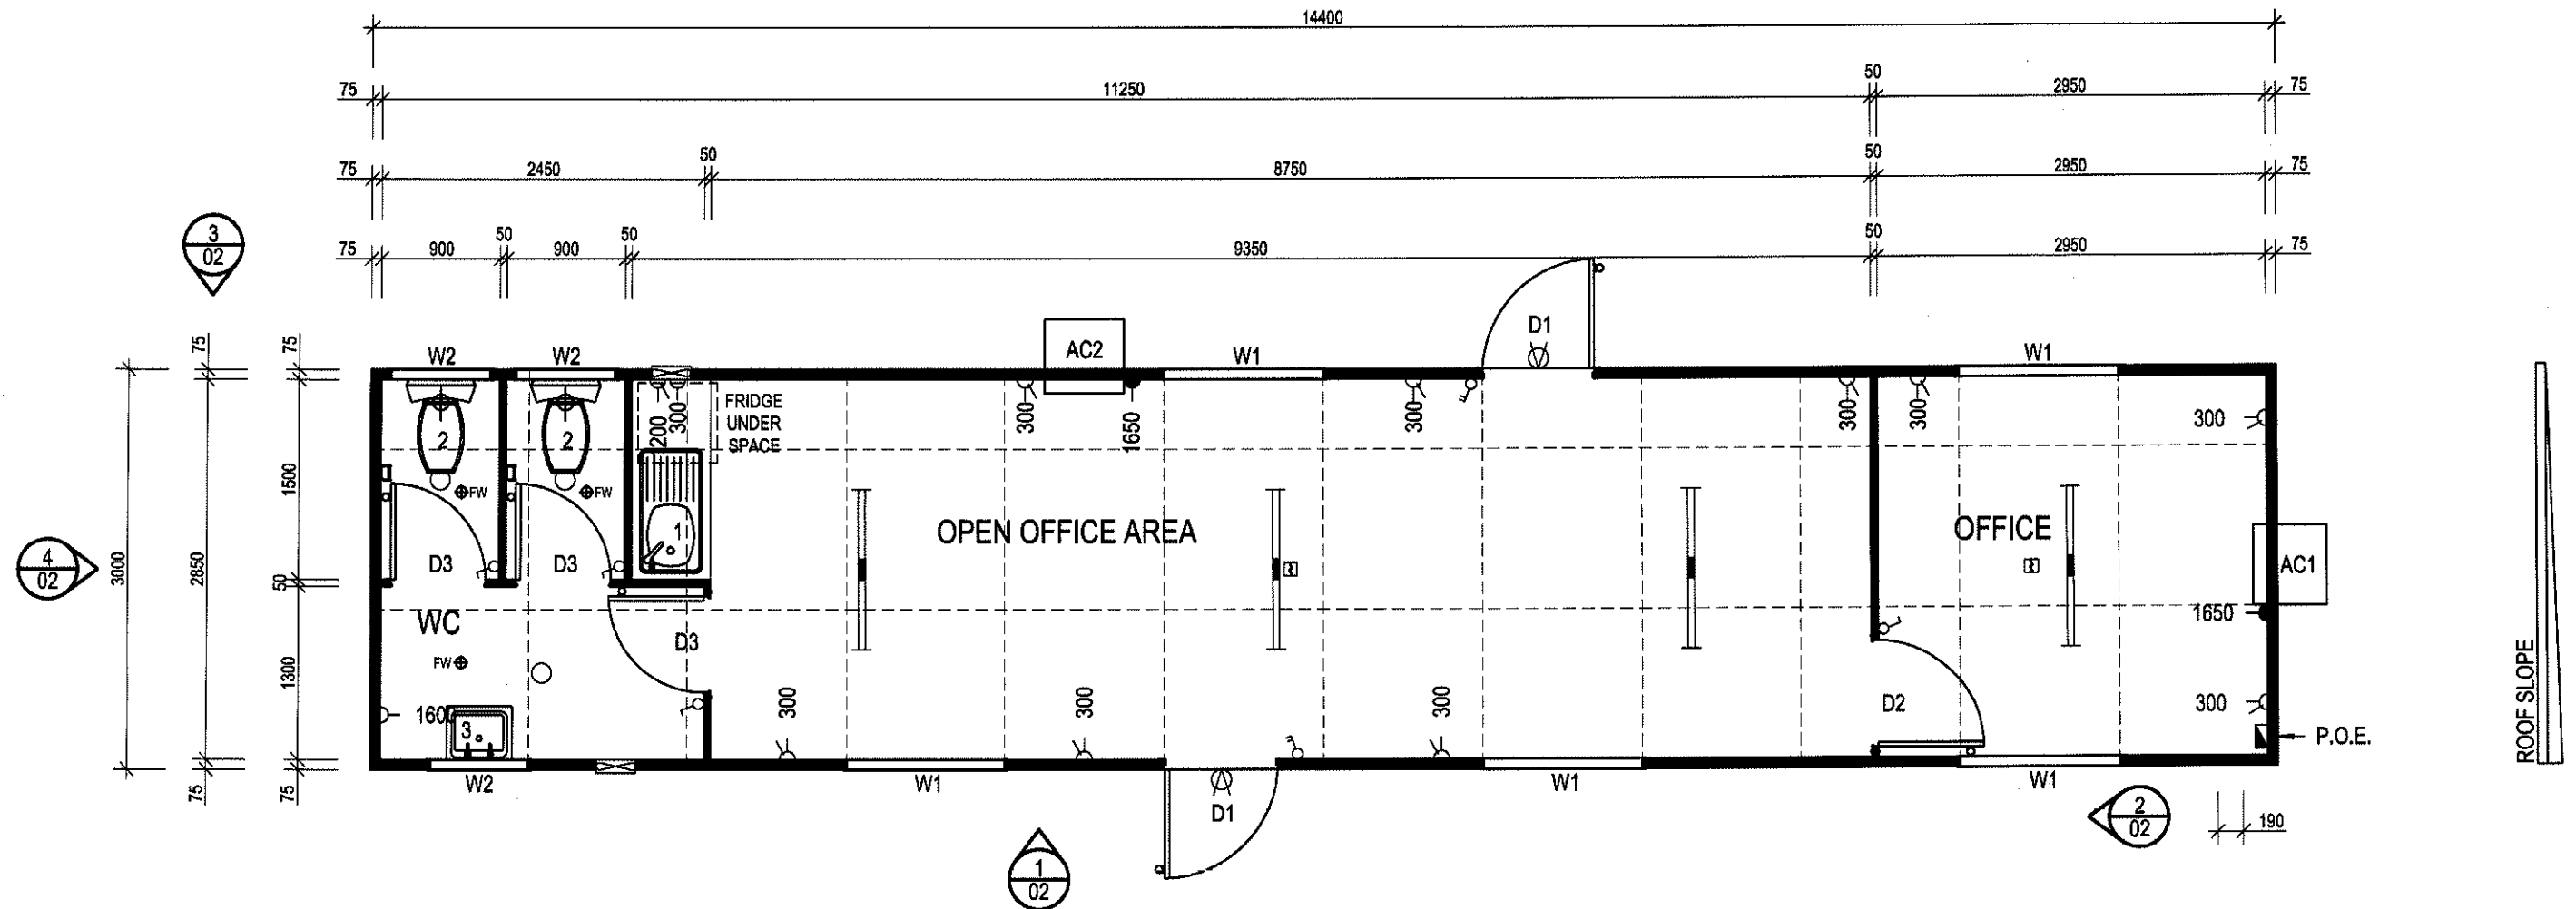

| EQUIPMENT LIST |                                                                          |     |
|----------------|--------------------------------------------------------------------------|-----|
| No.            | DESCRIPTION                                                              | QTY |
| D1             | 2040h x 820w PLAIN METAL EXTERNAL PANEL DOOR                             | 2   |
| D2             | 2040h x 820w HOLLOW CORE TIMBER INTERNAL DOOR                            | 1   |
| D3             | 2040h x 720w HOLLOW CORE TIMBER INTERNAL DOOR                            | 3   |
| W1             | 1050h x 1190w HORIZ. SLIDING WINDOW c/w FLYSCREEN                        | 5   |
| W2             | 350h x 750w ALUMINUM SLIDING WINDOW (OBSURED GLASS)                      | 3   |
| AC1            | WALL MOUNTED REVERSE CYCLE AIR CONDITIONER (1 HP)                        | 1   |
| AC2            | WALL MOUNTED REVERSE CYCLE AIR CONDITIONER (2 HP)                        | 1   |
| 1              | 600 WIDE LAM. BENCH c/w CUPB'DS BELOW & 930w S.S. SINK INSET - COLD ONLY | 1   |
| 2              | TOILET PAN c/w DUAL FLUSH CISTERN & PAPER HOLDER                         | 1   |
| 3              | S.S. HAND BASIN c/w MIRROR & SHELF OVER                                  | 1   |
|                |                                                                          |     |
|                |                                                                          |     |

### **PANEL BUILDING SHORT SPECIFICATION**

- CHASSIS - STEEL BEAMS c/w GALV. JOISTS 75 x 40 CEE SECTIONS @ MAX 400 CTRS
- FLOORING - 22mm T&G AQUATITE TERMITE TREATED PARTICLE BOARD
- FLOOR COVERING - 1.5mm VINYL FLOOR FINISH
- 2.0mm SLIP RESISTANT VINYL FLOOR FINISH c/w 100mm HIGH COVING TO WET AREAS
- EXTERNAL WALLS - 75mm PANEL c/w 0.4mm COLORBOND facings - refer colour schedule
- INTERNAL WALLS - 50mm PANEL c/w 0.4mm COLORBOND facings - refer colour schedule
- ROOF INSULATION - R1.8 POLYESTER INSULATION between ceiling joists with
- THERMALBREAK under roof sheets - TOTAL ROOF RATING R3.6
- ROOF & CEILING FRAME - GALV. STEEL FRAMEWORK
- ROOF CLADDING - SUPERDEK SHEETING - refer colour schedule
- CEILING - PRE-FINISHED PLYWOOD c/w ALUMINIUM CORNICE
- ROOF FLASHINGS & CORNER TRIMS - COLORBOND - refer colour schedule
- DOOR FRAMES - METAL POWDERCOATED FINISH - refer colour schedule
- INTERNAL DOOR FRAMES - ALUMINIUM POWDERCOATED FINISH - refer colour schedule

| <u><b>COLOUR SCHEDULE</b></u> |                 |
|-------------------------------|-----------------|
| ROOF DECKING                  | - COLORBOND     |
| ROOF FLASHING                 | - DEEP OCEAN    |
| EXTERNAL WALLS                | - PAPER BARK    |
| INTERNAL WALLS / DOORS        | - SURFMIST      |
| CEILING                       | - MIRAGE PEARL  |
| WINDOWS                       | - DEEP OCEAN    |
| EXTERNAL DOOR FRAME           | - DEEP OCEAN    |
| VINYL                         | - SLATE GREY    |
| VINYL TO WET AREAS            | - WOODLAND GREY |
| CUPB'D DOOR & SIDES           | - SOFT LEMON    |
| CUPB'D TOP & SHELVES          | - WHITE         |
| LOGOS                         | - YES           |
| PERIMETER / BASE CHANNEL      | - BLACK OXIDE   |

|                                                       |             |             |                                           |        |          |
|-------------------------------------------------------|-------------|-------------|-------------------------------------------|--------|----------|
|                                                       |             |             |                                           |        |          |
|                                                       |             |             |                                           |        |          |
| A                                                     | QUOTATION   |             |                                           | DD     | 17-03-10 |
| REV                                                   | DESCRIPTION |             |                                           | INIT   | DATE     |
| DRAWN BY:                                             | DATE:       | CHECKED BY: | DATE:                                     | SCALE: |          |
| Dauginas                                              | 17-03-10    |             |                                           | 1:50   |          |
| THIS DRAWING IS PROTECTED BY<br>COPYRIGHT LAWS © 2009 |             |             | DO NOT SCALE;<br>REFER TO DIMENSIONS ONLY |        |          |



|                                                                                                                                                         |                                               |
|---------------------------------------------------------------------------------------------------------------------------------------------------------|-----------------------------------------------|
| <b>HEAD OFFICE</b>                                                                                                                                      |                                               |
| <b>1240 ABERNETHY RD HIGH WYCOMBE W.A. 6057</b>                                                                                                         |                                               |
| <b>PH: (08) 9281 7500 FAX: (08) 9281 7580</b>                                                                                                           |                                               |
| <b>EMAIL: <a href="mailto:info@fleetwood.com.au">info@fleetwood.com.au</a> INTERNET: <a href="http://www.fleetwood.com.au">www.fleetwood.com.au</a></b> |                                               |
| <b>INTERSTATE BRANCHES:</b>                                                                                                                             | <b>555 WATERLOO CNR RD, BURTON S.A. 5110</b>  |
|                                                                                                                                                         | <b>PH: 8280 5500 FAX: 8280 5511</b>           |
| <b>DALGETY RD ALICE SPRINGS N.T. 0870</b>                                                                                                               | <b>58 McKINNON RD, BERRIMAH, DARWIN</b>       |
| <b>PH: 8952 1699 FAX: 8952 1177</b>                                                                                                                     | <b>N.T. 0820 PH: 8932 4800 FAX: 8932 4852</b> |

|                                                           |         |                  |                     |
|-----------------------------------------------------------|---------|------------------|---------------------|
| CLIENT:<br><b>WAY OUT BUSH STORE</b>                      |         |                  |                     |
| LOCATION:<br><b>TI TREE (CLOSE TO ALICE SPRINGS)</b>      |         |                  |                     |
| TITLE:<br><b>OFFICE / TOILET 14.4m x 3.0m - PLAN VIEW</b> |         |                  |                     |
| DWG No:<br><b>B01 - 01</b>                                | JOB No: | REV:<br><b>A</b> | SHEET:<br><b>A3</b> |