


| ELECTRICAL LEGEND |                               |
|-------------------|-------------------------------|
|                   | DBLE GPO @ 300 ABOVE F.L      |
|                   | SGLE GPO FOR A/C              |
|                   | CIRCUIT BOARD(POINT OF ENTRY) |
|                   | LIGHT SWITCH DOUBLE           |
|                   | DBLE FLUORESCENT 2 x 36w      |
|                   | EXTERNAL LIGHT                |

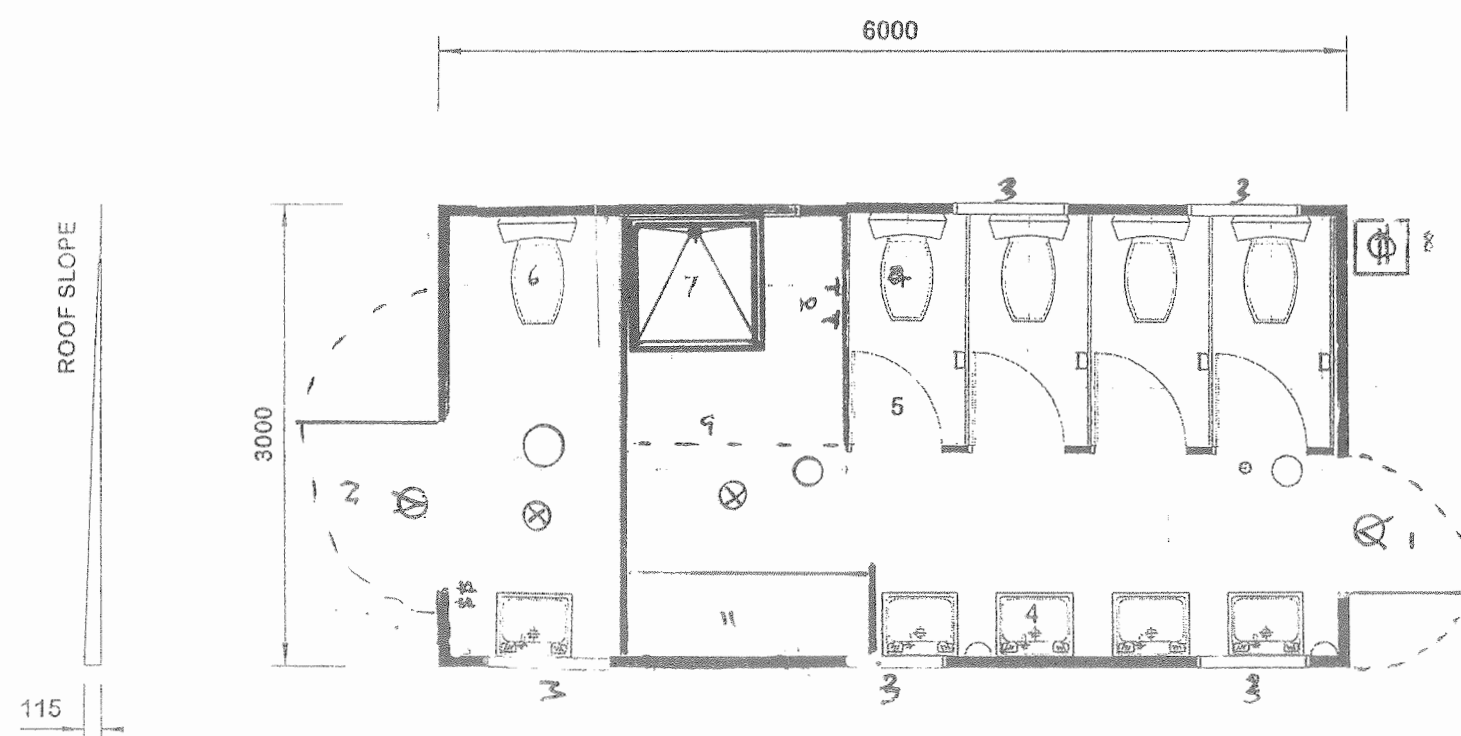

#### PANEL BUILDING SHORT SPECIFICATION :

- .. STEEL CHASSIS C/W GALV. JOISTS 75 x 40 x 1.6mm @ MAX 400 CTRS
- .. 15mm PLYWOOD FLOORING
- .. 1.5mm VINYL FLOOR FINISH
- .. WALLS EXT 75mm PANEL c/w 0.4mm C/BOND FACINGS
- .. 75mm FIBRE GLASS R1.8 INSULATION TO ROOF BETWEEN CEILING JOISTS
- .. GALV. STEEL CEILING / ROOF FRAME WITH ZINCALUME DECKING
- .. CEILING HEIGHT ..2400..
- .. PRE-FINISHED PLYWOOD CEILINGS c/w ALUMIN. CORNICE
- .. COLORBOND ROOF FLASHINGS & CORNER TRIMS

#### EQUIPMENT LIST:

- 1.. 2040 x 870 PLAIN METAL EXTERNAL DOOR
- 2 750 x 350 HORIZ. SLIDING WINDOW C/W FLYSCREEN
- 2 1200 x 2060 PLAIN METAL DOOR
- 4 WHITE TOILET SET
- 5 800 WIDE TOILET CUBICLES
- 6 DISABLED TOILET SET
- 7 900 x 900 SHOWER
- 8 160 LTR ELEC. H.W.S.
- 9 SHOWER CURTAINS & ROD
- 10 COAT HOOKS
- 11 CHANGE TABLE

#### BUILDING DESIGN CRITERIA

Wind Load - in Accordance with AS.1170.2:2002  
REGION A, TERRAIN CATEGORY 2  
Annual Probability of Exceedance 1:500  
REGIONAL WIND SPEED - V500 = 45 m/s

REGION A - All glazing & window assemblies shall comply with the following requirements:  
Australian Standard AS 2047 - Windows in buildings  
Water Penetration Resistance Test Pressure 150 Pa  
Ultimate Strength Test Pressure 1300 Pa

|                                                                                                                                                 |                                                                                                                                                                                                                                                                                                                                                                                                                                                                                                                                                                                                |  |                         |  |                   |  |
|-------------------------------------------------------------------------------------------------------------------------------------------------|------------------------------------------------------------------------------------------------------------------------------------------------------------------------------------------------------------------------------------------------------------------------------------------------------------------------------------------------------------------------------------------------------------------------------------------------------------------------------------------------------------------------------------------------------------------------------------------------|--|-------------------------|--|-------------------|--|
| <div>NOTE:<br/>THESE DRAWING ARE<br/>PROTECTED BY<br/>COPYRIGHT LAWS...</div> <div>DO NOT SCALE<br/>DRAWINGS..REF<br/>TO DIMENSIONS ONLY.</div> | <div><div>Fleetwood</div><div>PORTABLES</div></div> <div>555 WATERLOO CNR RD, BURTON S.A. 5110<br/>PH: 8280 5500 FAX: 8280 5511</div> <div>LOT 1101 - 1102 MOOLIGUNN RD, KARRATHA<br/>W.A. 6714 PH: 9144 4400 FAX: 9144 4430</div> <div>HEAD OFFICE<br/>21 CASINO ST WELSHPOOL W.A 6105<br/>PH: 9353 2822 FAX: 9353 3866</div> <div>DALGETY RD ALICE SPRINGS N.T. 0870<br/>PH: 8952 1699 FAX: 8952 1177</div> <div>LOT 1690 MCKINNON RD, BERRIMAH, DARWIN<br/>N.T. 0820 PH: 8932 4900 FAX: 8932 4888</div> |  | <div>D201426</div>      |  |                   |  |
|                                                                                                                                                 | CLIENT: FLEETWOOD PORTABLES                                                                                                                                                                                                                                                                                                                                                                                                                                                                                                                                                                    |  | ORIGINAL SCALE:<br>1:50 |  |                   |  |
|                                                                                                                                                 | TITLE: STANDARD O2-A                                                                                                                                                                                                                                                                                                                                                                                                                                                                                                                                                                           |  | DWN BY:<br>DCT          |  | DATE:<br>24.10.03 |  |
|                                                                                                                                                 | 6 x 3m OFFICE                                                                                                                                                                                                                                                                                                                                                                                                                                                                                                                                                                                  |  | DWG No<br>O2-A          |  | REV:              |  |
|                                                                                                                                                 |                                                                                                                                                                                                                                                                                                                                                                                                                                                                                                                                                                                                |  |                         |  |                   |  |